
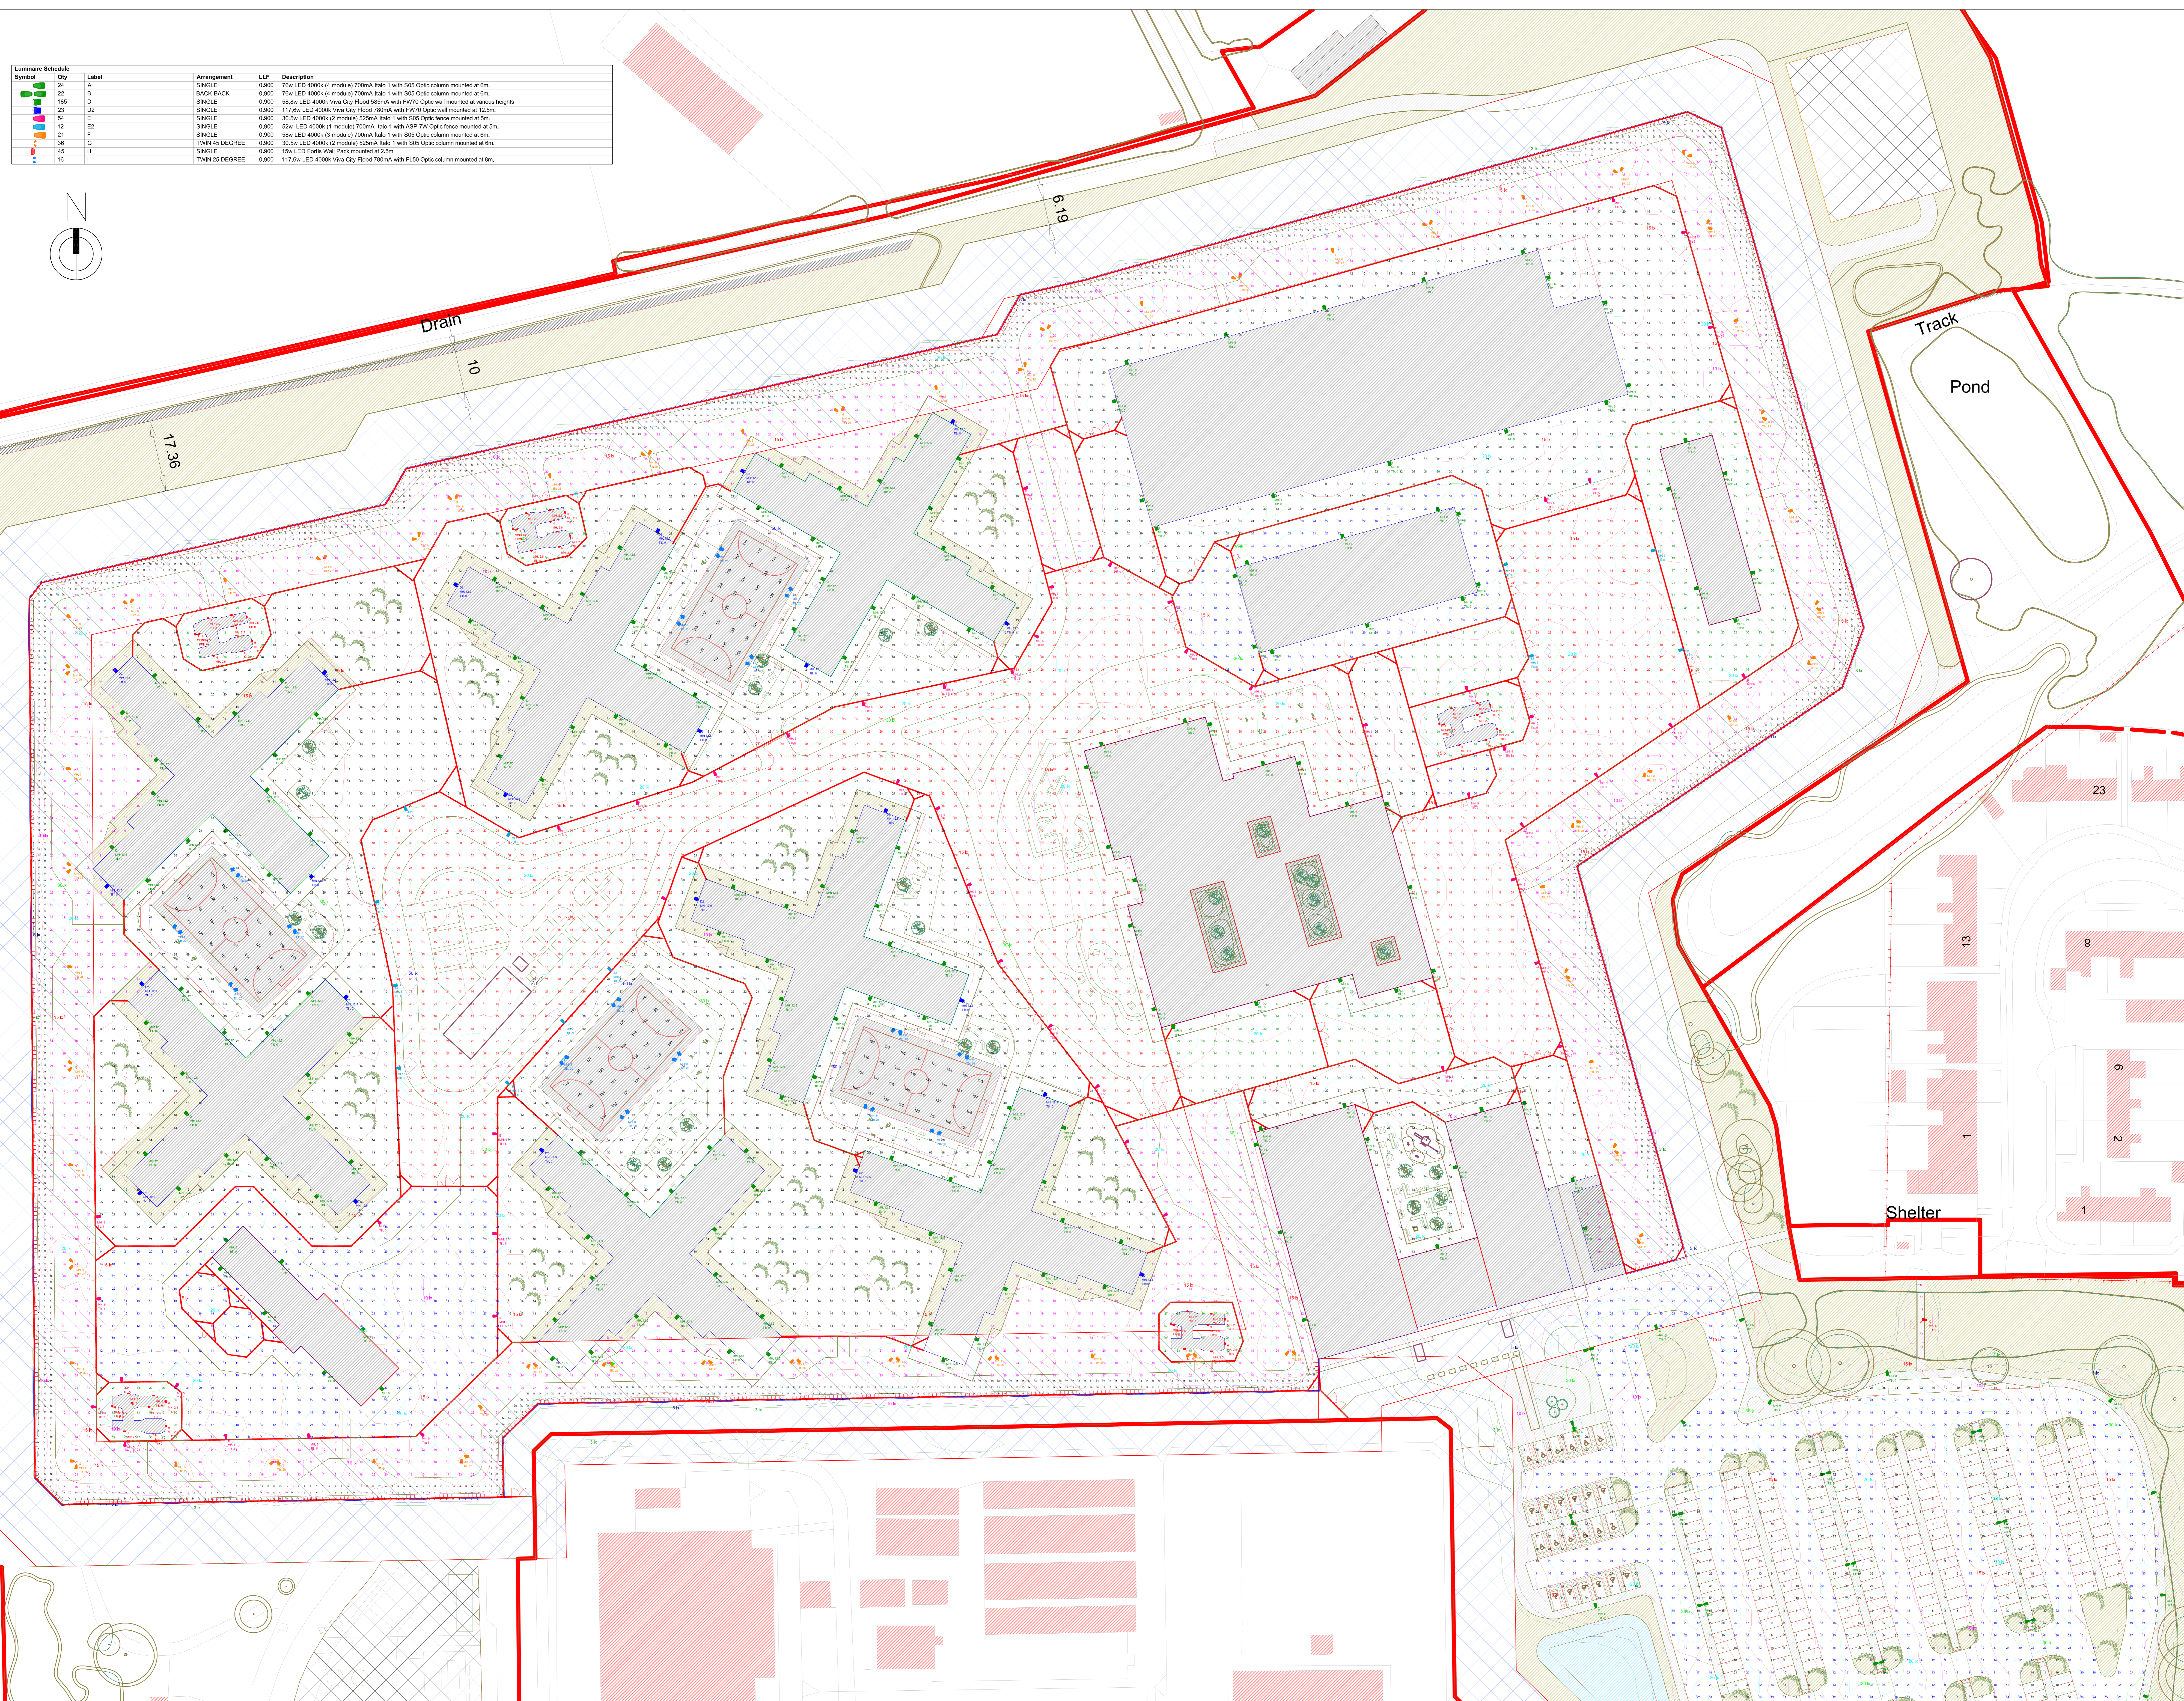


Luminaire Schedule	Qty	Label	Arrangement	LLF	Description
A	24	A	SINGLE	0.900	76w LED 4000K (4 module) 700mA Halo 1 with 505 Optic column mounted at 6m.
B	22	B	BACK-TO-BACK	0.900	76w LED 4000K (4 module) 700mA Halo 1 with 505 Optic column mounted at 6m.
D	185	D	SINGLE	0.900	56.5w LED 4000K Viva City Flood 525mA with F150 Optic wall mounted at various heights
D2	23	D2	SINGLE	0.900	117.8w LED 4000K Viva City Flood 780mA with F150 Optic wall mounted at 12.5m.
E	54	E	SINGLE	0.900	30.5w LED 4000K (2 module) 525mA Halo 1 with 505 Optic fence mounted at 5m.
E2	12	E2	SINGLE	0.900	52w LED 4000K (1 module) 700mA Halo 1 with 458-70 Optic fence mounted at 5m.
F	21	F	SINGLE	0.900	56w LED 4000K (3 module) 700mA Halo 1 with 505 Optic column mounted at 6m.
G	36	G	TWIN 45 DEGREE	0.900	30.5w LED 4000K (2 module) 525mA Halo 1 with 505 Optic column mounted at 6m.
H	45	H	SINGLE	0.900	15w LED Forme Wall/Fence mounted at 2.5m
I	16	I	TWIN 25 DEGREE	0.900	117.8w LED 4000K Viva City Flood 780mA with F150 Optic column mounted at 6m.

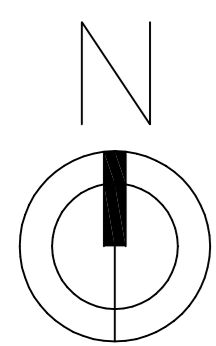

© Crown copyright 2018
 Do not scale from drawings. Verify all dimensions on site prior to construction. This drawing is to be read in conjunction with all relevant documents and drawings. Report all discrepancies to MUI immediately.
 No unauthorised use, disclosure, storage or copying.

Notes
 1. To be read in conjunction with 608623-0000-PEV-GH0011-ZZ-DR-E-6311 External Lighting Report

Rev	Date	Description
P02	16.07.21	Site plan revised
P01	12.04.21	First Issue

Project Status
 RIBA Stage 2

Client
Ministry of Justice
 Ministry of Justice, 102 Petty France, London, SW1H 9AJ

Project Name / Site
 New Prisons Programme
 Garth Wymott - 2

Project Address
 Site Adjacent to HMP Garth & HMP Wymott

Originator Logo	Drawn By	CJR	Date	12.04.21
PICK EVERARD	Checked By	AR	Date	12.04.21
	Approved By	AR	Date	12.04.21
Drawing Number	608623-0000-PEV-GH0011-ZZ-DR-E-6311			Delref
Sheet No.	2 of 3	Scale	Orig. Sheet Size	Rev.
	NTS	@A0	P02	
Data Handling Classification	OFFICIAL	Suitability	53	